



NEW SOUTHEASTERN EMS FOR RUTHERFORD COUNTY North Carolina

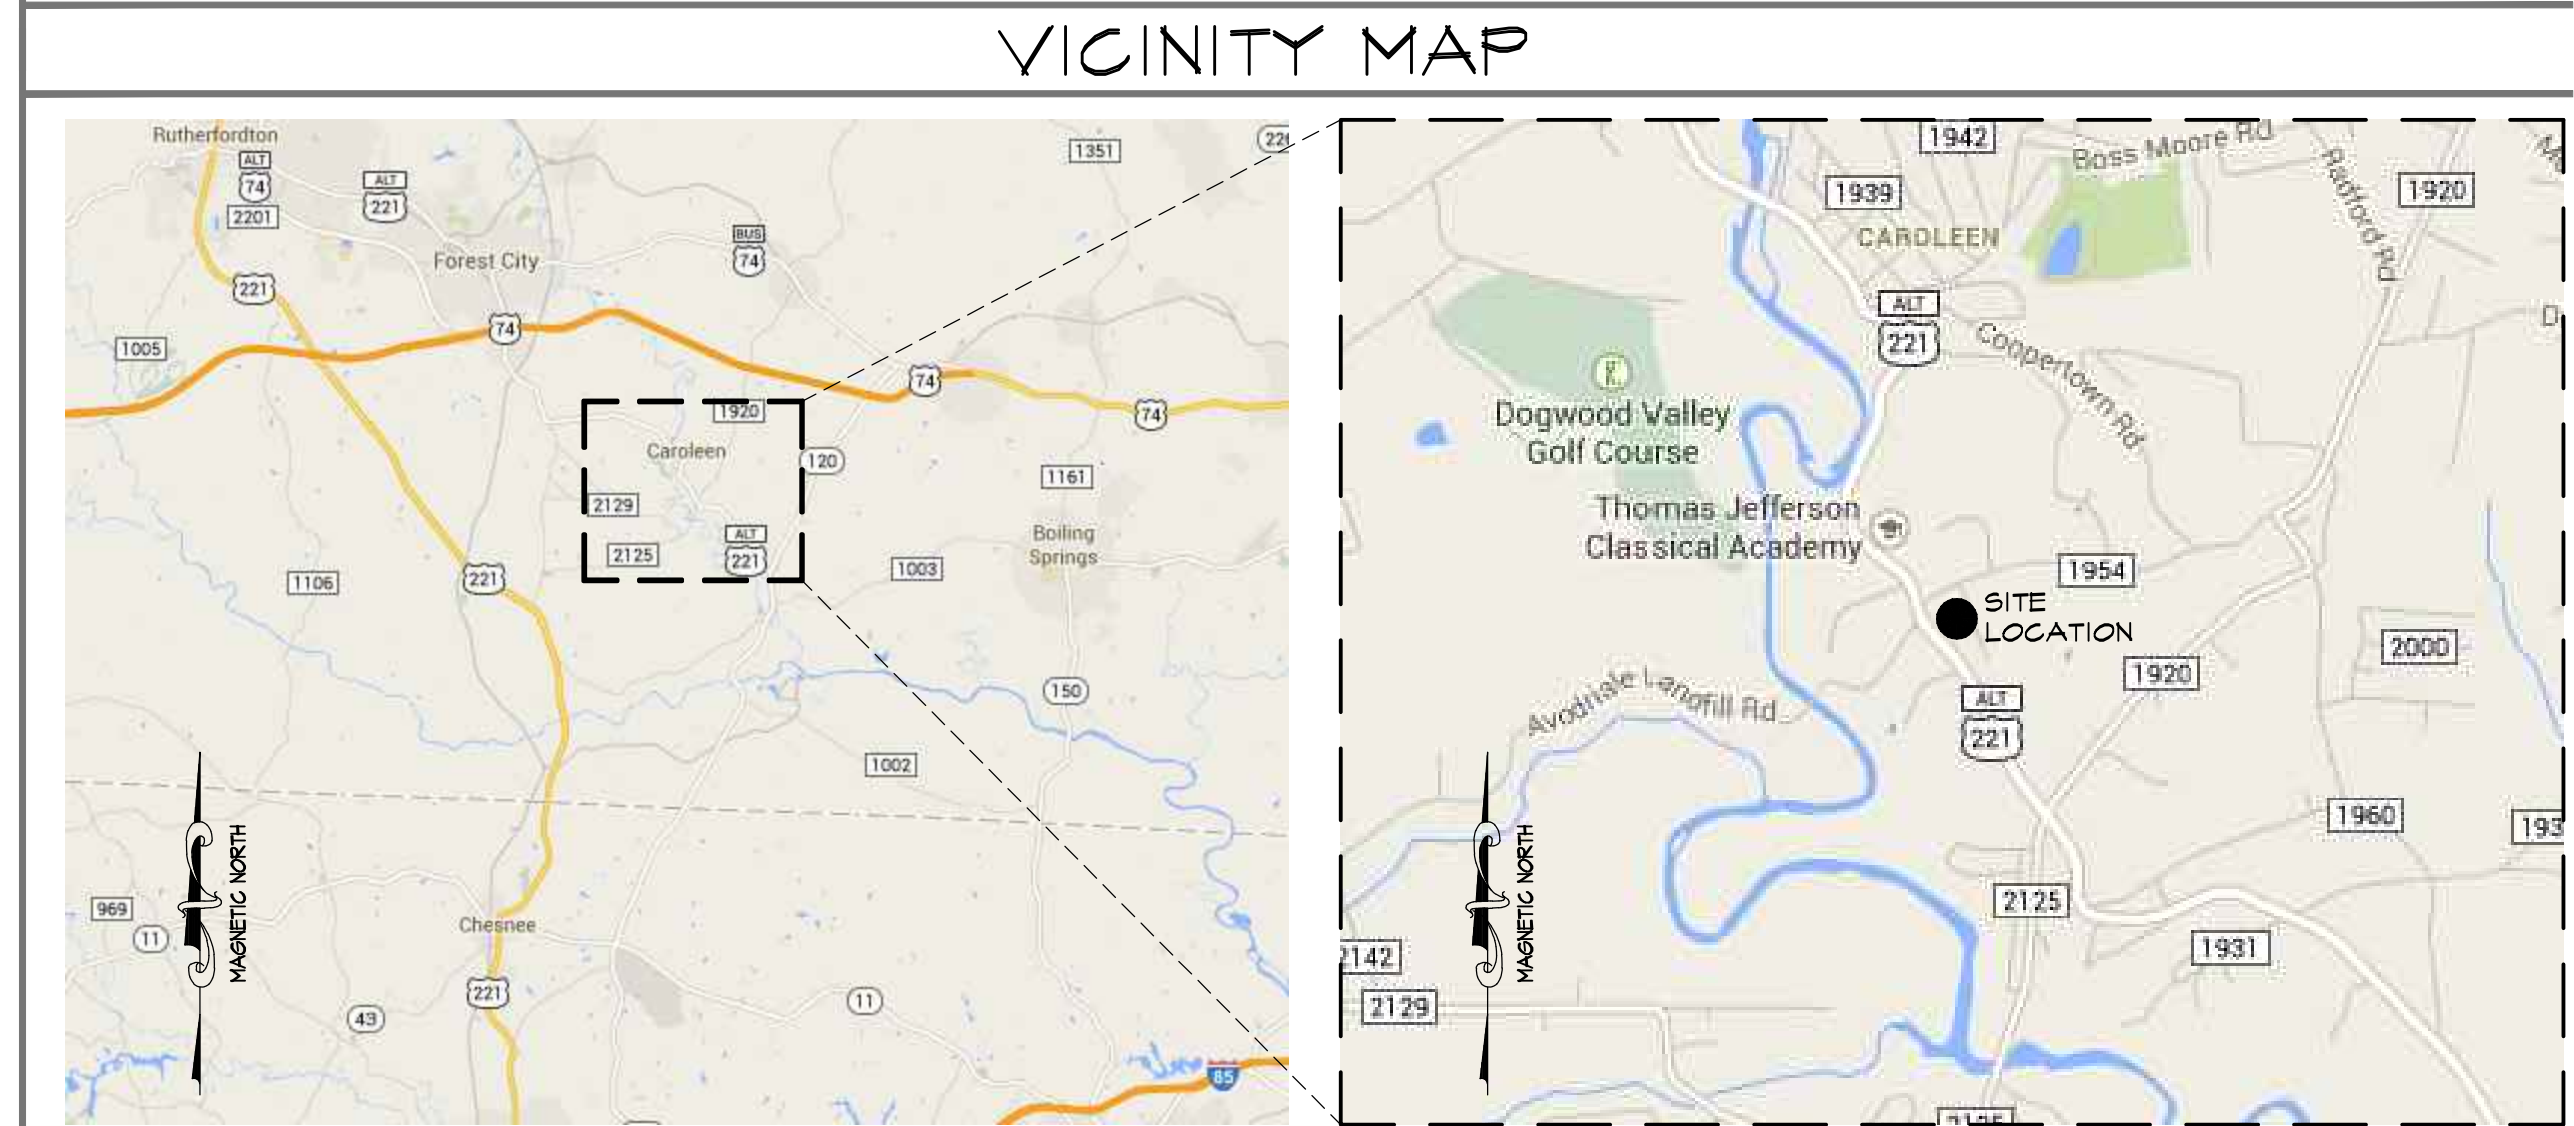

architecture • interior design
1300 South Mint Street, Suite 300, Charlotte, NC 28203
Email: esd@esdarch.com • Fax: 704-373-0902 • Phone: 704-373-1900

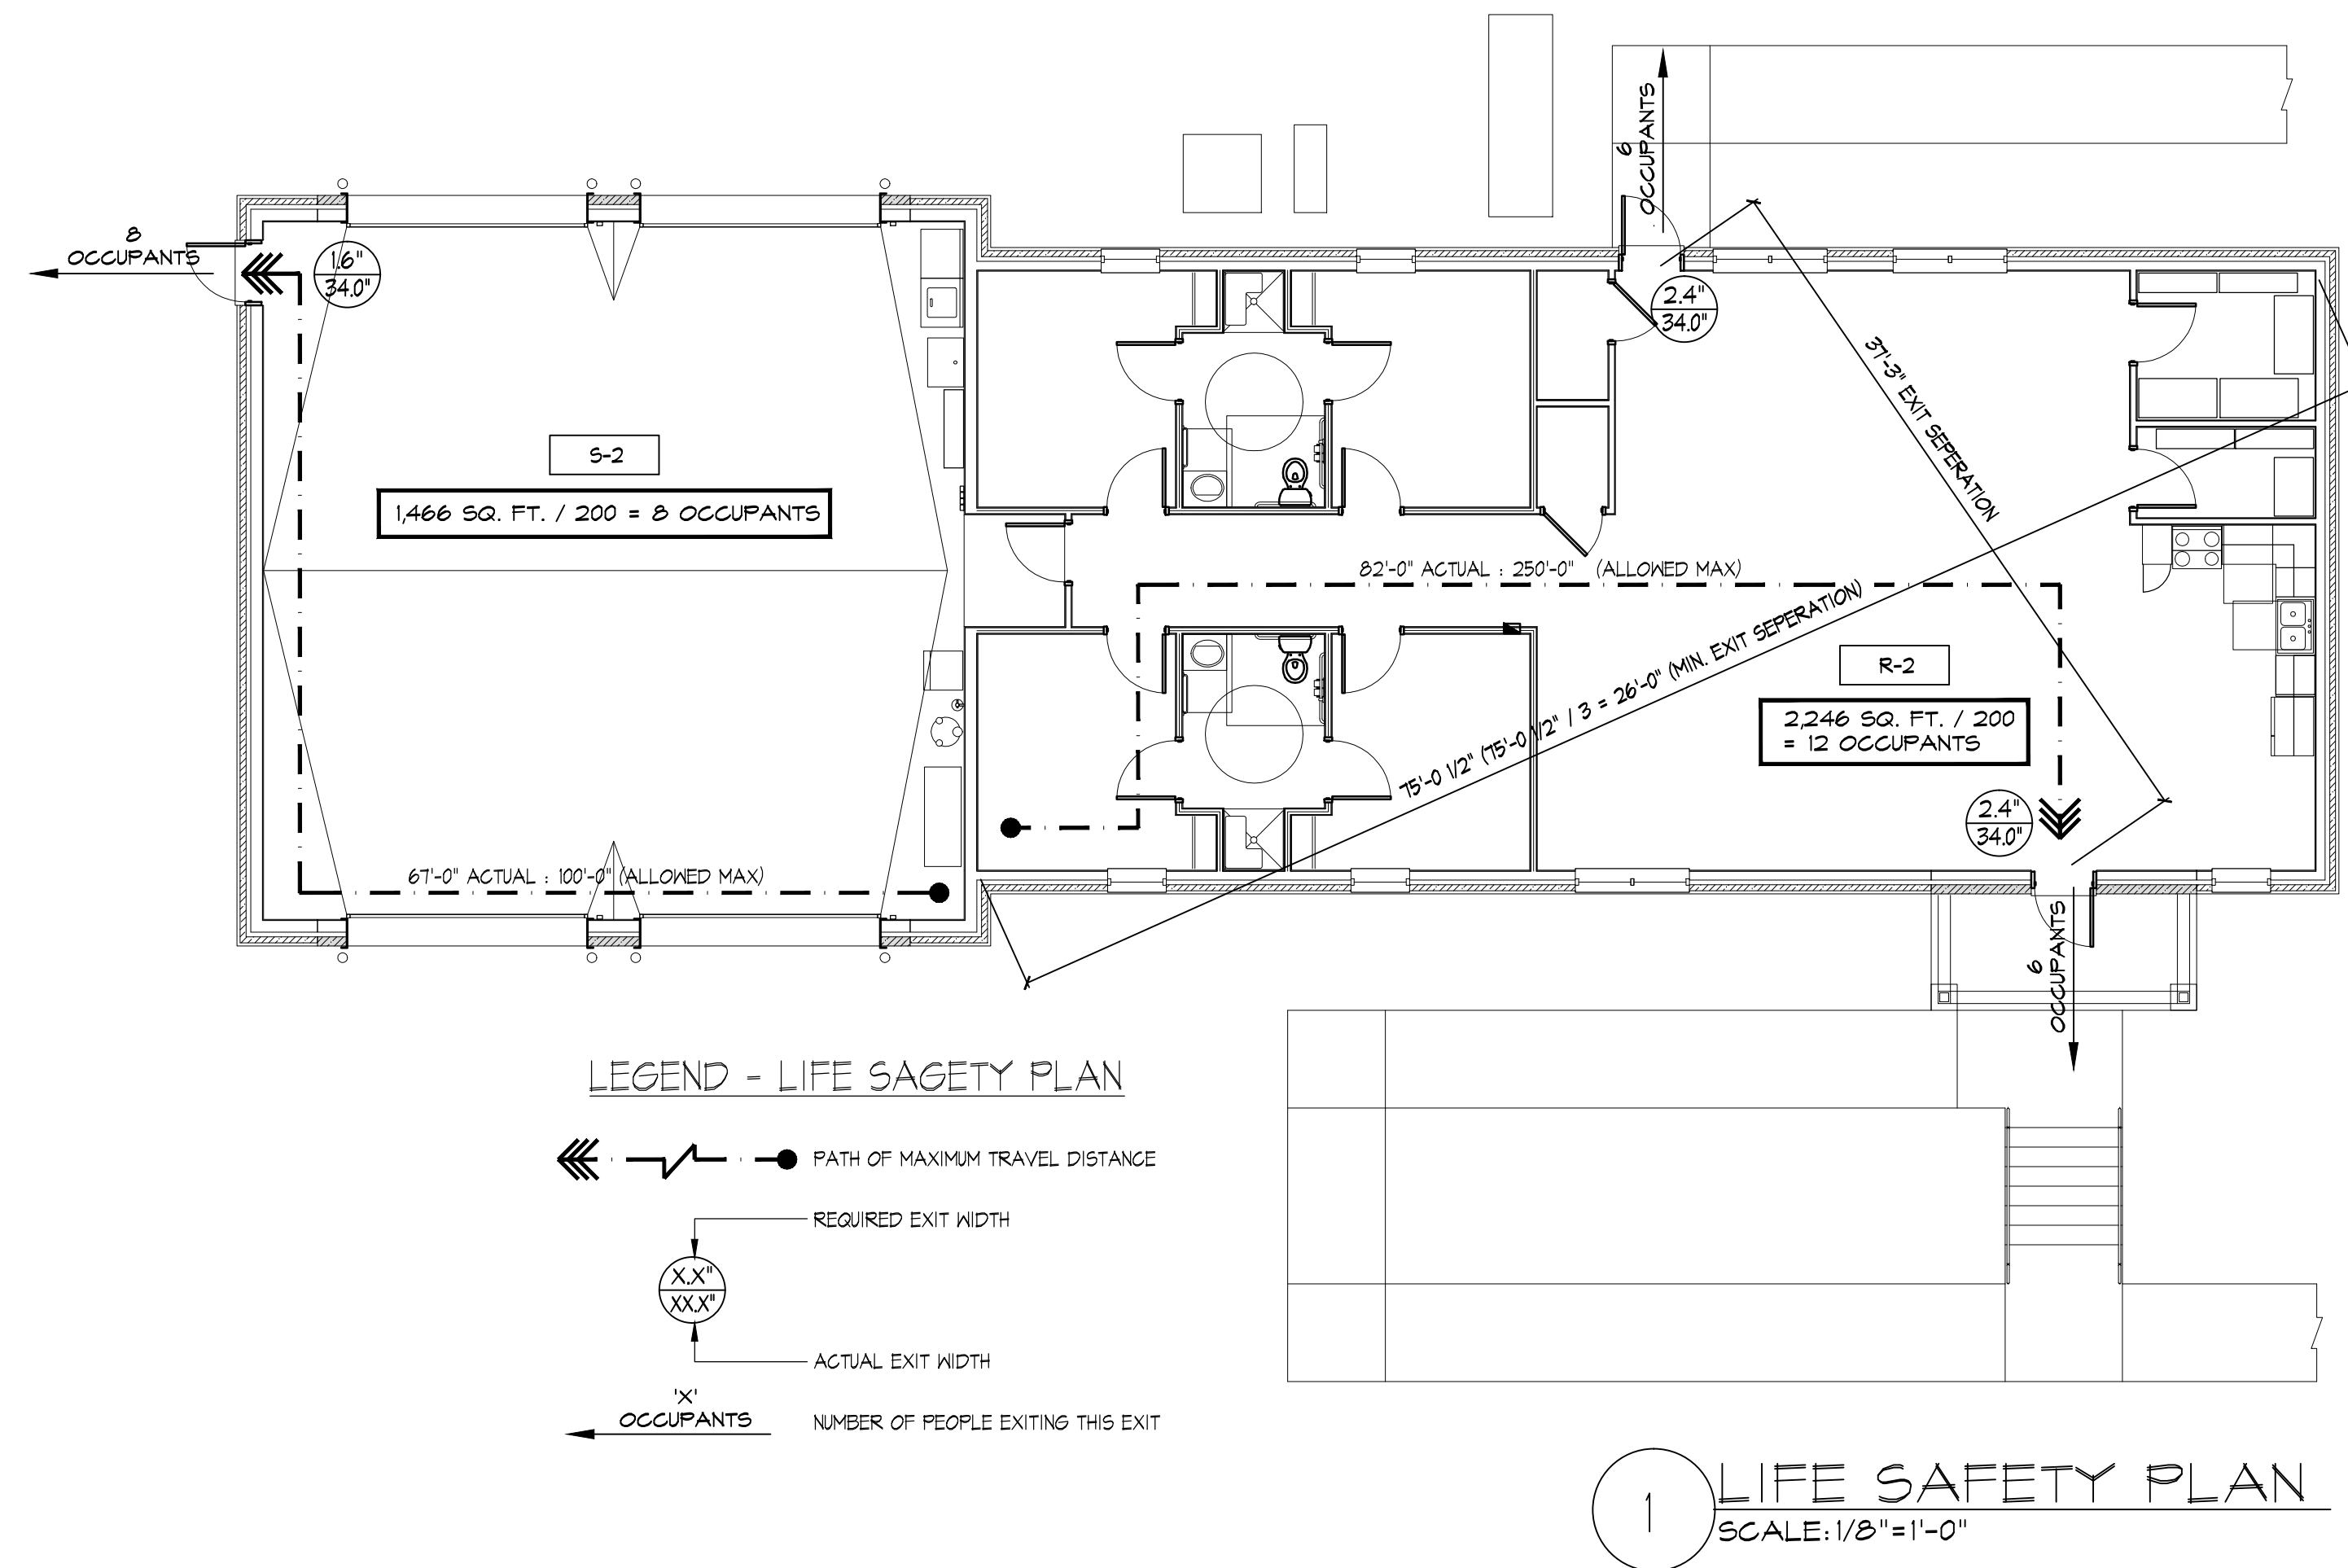

**NEW SOUTHEASTERN EMS
FOR
RUTHERFORD COUNTY
North Carolina**

ABBREVIATIONS

ACT = ACOUSTICAL CEILING TILE	EXIST. = EXISTING	MIN. = MINIMUM	T.O.P. = TOP OF PARAPET
ADA = AMERICANS WITH DISABILITIES ACT	EXIST'G = EXISTING	M.O. = MASONRY OPENING	T.O.R. = TOP OF ROOF
ADJ. = ADJUSTABLE	EXP. = EXPANSION	MTD. = MOUNTED	T.O.S. = TOP OF STEEL
A.F.F. = ABOVE FINISHED FLOOR	EXT. = EXTERIOR	N. = NORTH	T.O.W. = TOP OF WALL
ALUM = ALUMINUM	F.A. = FIRE ALARM	N.I.C. = NOT IN CONTRACT	TELE = TELEPHONE
B.E. = BANK EQUIPMENT	F.D. = FLOOR DRAIN	N/A = NOT APPLICABLE	TRI. = TRIPLE
BLDG = BUILDING	F.E. = FIRE EXTINGUISHER	NR = NOT RATED	TYP. = TYPICAL
C.B. = CATCH BASIN	F.E.C. = FIRE EXTINGUISHER CABINET	O.D. = OUTSIDE DIAMETER	V.C.T. = VINYL COMPOSITION TILE
C.E. = CEVENT	F.F. = FINISHED FLOOR	O.C. = ON CENTER	VERT. = VERTICAL
C.T. = CERAMIC TILE	FIN. = FINISH	OPP. = OPPOSITE	V.I.F. = VERIFY IN FIELD
CLR = CLEAR	FL. = FLOOR	O.H. = OPPOSITE HAND	U.O.N. = UNLESS OTHERWISE NOTED
CL.G. = CEILING	FLR. = FLOOR	PL. = PLATE	U.N.O. = UNLESS NOTED OTHERWISE
COL. = COLUMN	FLUOR. = FLUORESCENT	P.L.M.B. = PLUMBING	W. = WITH
CONC. = CONCRETE	F.O.F. = FACE OF FINISH	P-LAM = PLASTIC LAMINATE	W/O = WITHOUT
CONT. = CONTINUOUS	F.O.S. = FACE OF STUD	FR = PAIR	W.C. = WATER CLOSET
CMU = CONCRETE MASONRY UNIT	FOM. = FACE OF MASONRY	P.T. = PRESSURE TREATED	WD. = WOOD
CPT. = CARPET	FT. = FOOT	P.T.F. = PRESSURE TREATED, FIRE RETARDANT	WH. = WATER HEATER
DIA. = DIAMETER	FTG. = FOOTING	R. = RADIUS	WP. = WATERPROOF
D.B. = DOOR BELL	FURR. = FURRING	R.D. = ROOF DRAIN	WR. = WATER RESISTANT
D.F. = DRINKING FOUNTAIN	FUT. = FUTURE	REF. = REFRIGERATOR	WT. = WEIGHT
DBL. = DOUBLE	GA. = GAUGE	REQ. = REQUIRED/REQUIREMENT	
DEM0 = DEMOLITION	GALV. = GALVANIZED	RM. = ROOM	
DIM. = DIMENSION	G.B. = GRAB BAR	R.O. = ROUGH OPENING	
DISP. = DISPENSER	GL. = GLASS/GLAZING	SIM. = SIMILAR	
DN. = DOWN	GND. = GROUND	SPEC. = SPECIFICATION	
D.O. = DOOR OPENING	GYP. BD. = GYPSUM BOARD	STC. = SOUND TRANSMISSION GLASS	
DR. = DOOR	GR. = GROUT	STL. = STEEL	
DS. = DOWN SPOUT	H.C. = HOLLOW CORE	STOR. = STORAGE	
DTL. = DETAIL	H.M. = HOLLOW METAL	S.S. = STAINLESS STEEL	
DWG. = DRAWING	HDR. = HARDWARE	SUSP. = SUSPENDED	
EA. = EACH	HORIZ. = HORIZONTAL		
E.J. = EXPANSION JOINT	I.D. = INSIDE DIAMETER		
ELEC. = ELECTRICAL	INSUL. = INSULATION		
ELEV. = ELEVATOR	INT. = INTERIOR		
EMER. = EMERGENCY	JAN. = JANITOR		
EO. = EQUAL/EQUIDISTANT	JT. = JOINT		
E.W.C. = ELECTRIC WATER COOLER	LAV. = LAVATORY		
	MTL. = METAL		
	MFR. = MANUFACTURE/MANUFACTURER		

SHEET INDEX:

GENERAL	STRUCTURAL	FIRE PROTECTION
A-0.0 COVER	5-0.0 GENERAL NOTES AND SPECIFICATIONS	FP-1.1 FIRE PROTECTION PLAN
A-0.1 BUILDING CODE SUMMARY	5-0.1 QUALITY ASSURANCE PLAN	PLUMBING
A-0.2 ULR205 DETAILS	5-1.0 FOUNDATION PLAN	P-1.1 PLUMBING PLAN
	5-1.1 ROOF FRAMING PLAN	P-2.1 PLUMBING DETAILS
	5-2.0 CONSTRUCTION DETAILS	P-2.2 PLUMBING SCHEDULES
	5-2.1 CONSTRUCTION DETAILS	MECHANICAL
CIVIL/SITE	ARCHITECTURAL	M-1.1 MECHANICAL PLAN
C1 COVER SHEET	A-1.1 FLOOR PLAN	M-2.1 SCHEDULES AND COMPLIANCE STATEMENT
C2 EXISTING CONDITIONS	A-1.2 REFLECTED CEILING PLAN	M-3.1 DETAILS AND SPECIFICATIONS
C3 PHASE 1	A-1.3 ROOF PLAN	ELECTRICAL
C4 OVERALL PLAN	A-1.4 ENLARGED ADA PLAN DETAILS	E-1.0 SYMBOLS AND SCHEDULES
C5 DRAINAGE PLAN	A-2.1 DOOR, WINDOW, & FINISH SCHEDULES	E-1.1 ELECTRICAL SITE PLAN
C6 UTILITIES PLAN	A-3.1 EXTERIOR ELEVATIONS	E-2.1 LIGHTING PLAN
C7 STORM WATER PLAN	A-3.2 EXTERIOR ELEVATIONS	E-3.1 POWER PLAN
C8 ECP DETAILS	A-4.1 BUILDING SECTIONS	E-4.1 RISER DIAGRAMS
	A-4.2 WALL SECTIONS	E-5.1 DETAILS
	A-4.3 WALL SECTIONS	
	A-4.4 WALL SECTIONS	
	A-4.5 WALL SECTIONS	

ISSUE DATE: 10-7-2014
REVISION 1: --
REVISION 2: --
REVISION 3: --
REVISION 4: --
PROJECT #: 14-190-000
CONTENT: COVER
SHEET INDEX

PROJECT ARCHITECT: --
DRAWN BY: SJP

CADD FILE NAME:
a-0.0 cover.dwg

THIS DRAWING AND THE DESIGN SHOWN ARE THE PROPERTY OF ESD. THE REPRODUCTION, OR USE OF THIS DRAWING WITHOUT THEIR WRITTEN CONSENT IS PROHIBITED. ANY INFRINGEMENT IS SUBJECT TO LEGAL ACTION.

Sheet
A-0.0