


2 CONC. STAIR DETAIL  
SCALE: 1"=1'-0"

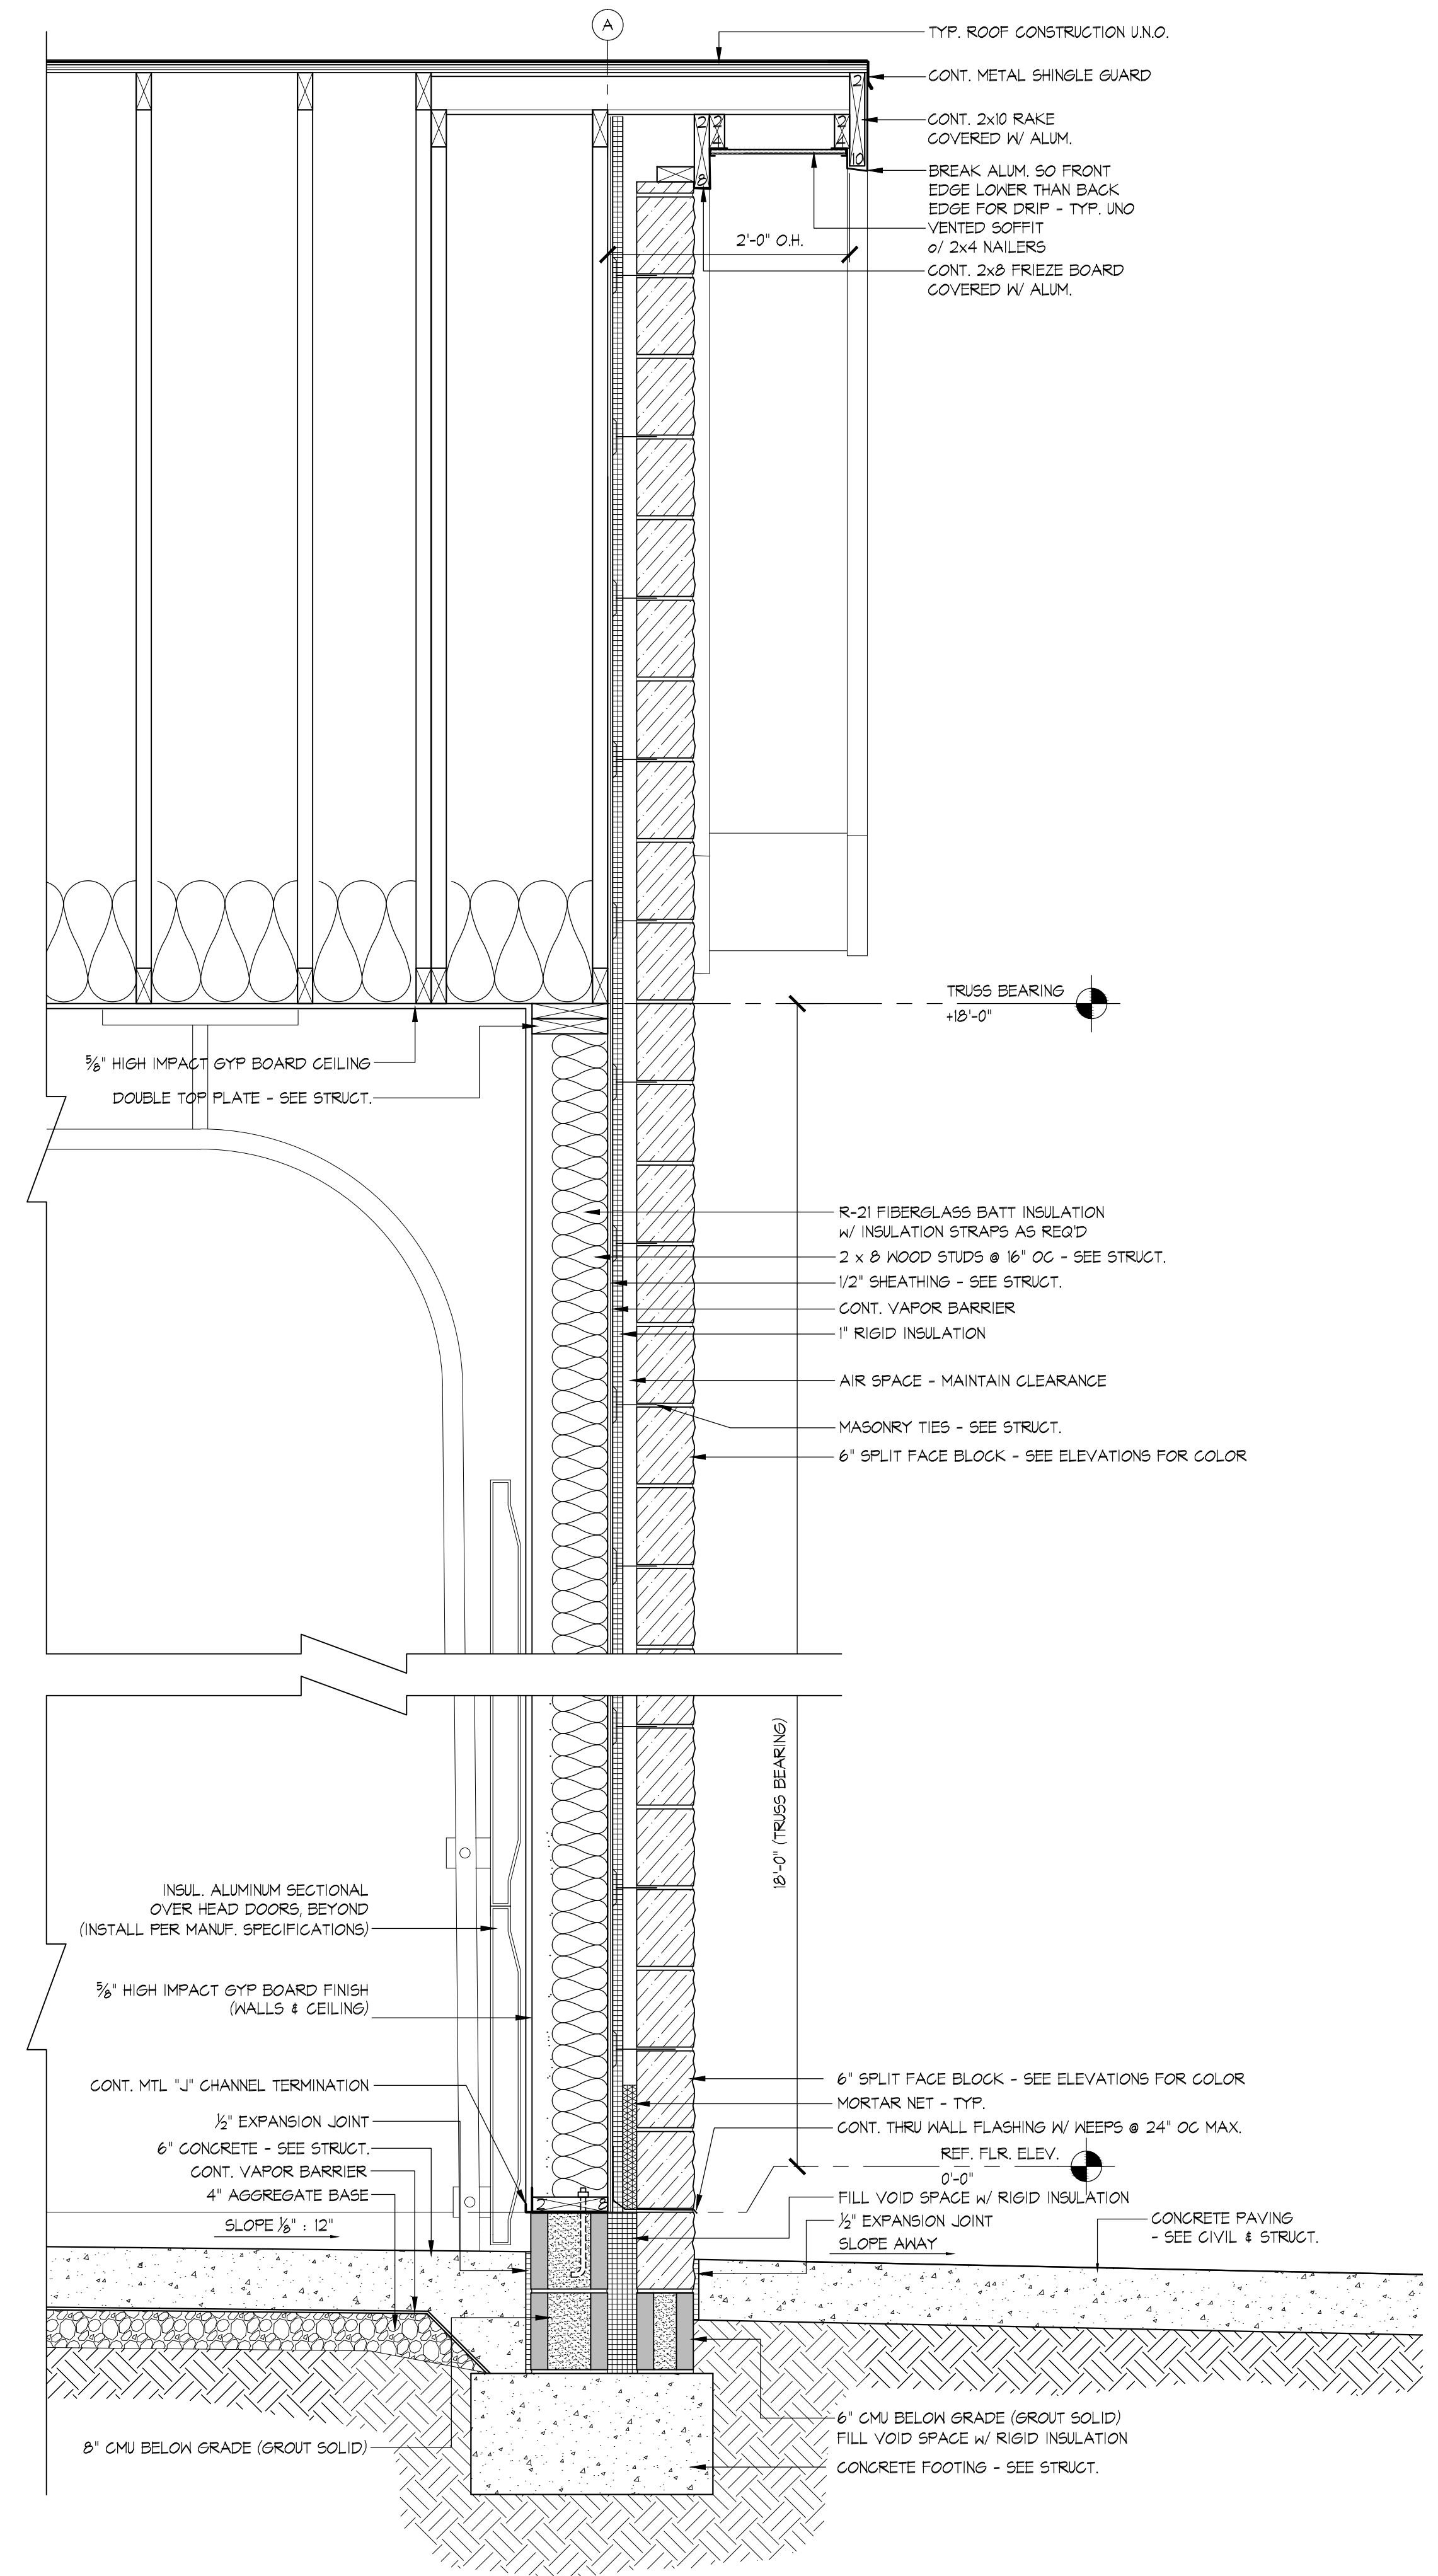

1 WALL SECTION  
SCALE: 1"=1'-0"

**SOUTHEASTERN EMS**  
NEW SOUTHEASTERN EMS  
FOR  
RUTHERFORD COUNTY

ISSUE DATE: 10-7-2014  
REVISION 1: --  
REVISION 2: --  
REVISION 3: --  
REVISION 4: --  
PROJECT #: 14-190-000  
CONTENT: DETAIL SECTIONS  
PROJECT ARCHITECT: --  
DRAWN BY: SJP  
CADD FILE NAME:

THIS DRAWING AND THE DESIGN SHOWN ARE THE PROPERTY OF ESD. THE REPRODUCTION, OR USE OF THIS DRAWING, WITHOUT THEIR WRITTEN CONSENT IS PROHIBITED. ANY INFRINGEMENT IS SUBJECT TO LEGAL ACTION.