




**SOUTHEASTERN EMS
NEW SOUTHEASTERN EMS
FOR
RUTHERFORD COUNTY**

ISSUE DATE: 10-7-14
REVISION 1: _____
REVISION 2: _____
REVISION 3: _____
REVISION 4: _____
PROJECT #: 14-190-000
CONTENT: _____

PROJECT ENGINEER: MPA
DRAWN BY: MHK
CADD FILE NAME: _____

THIS DRAWING AND THE DESIGN SHOWN ARE THE PROPERTY OF ESD. THE REPRODUCTION, OR USE OF THIS DRAWING WITHOUT THE WRITTEN CONSENT IS PROHIBITED. ANY INFRINGEMENT IS SUBJECT TO LEGAL ACTION.

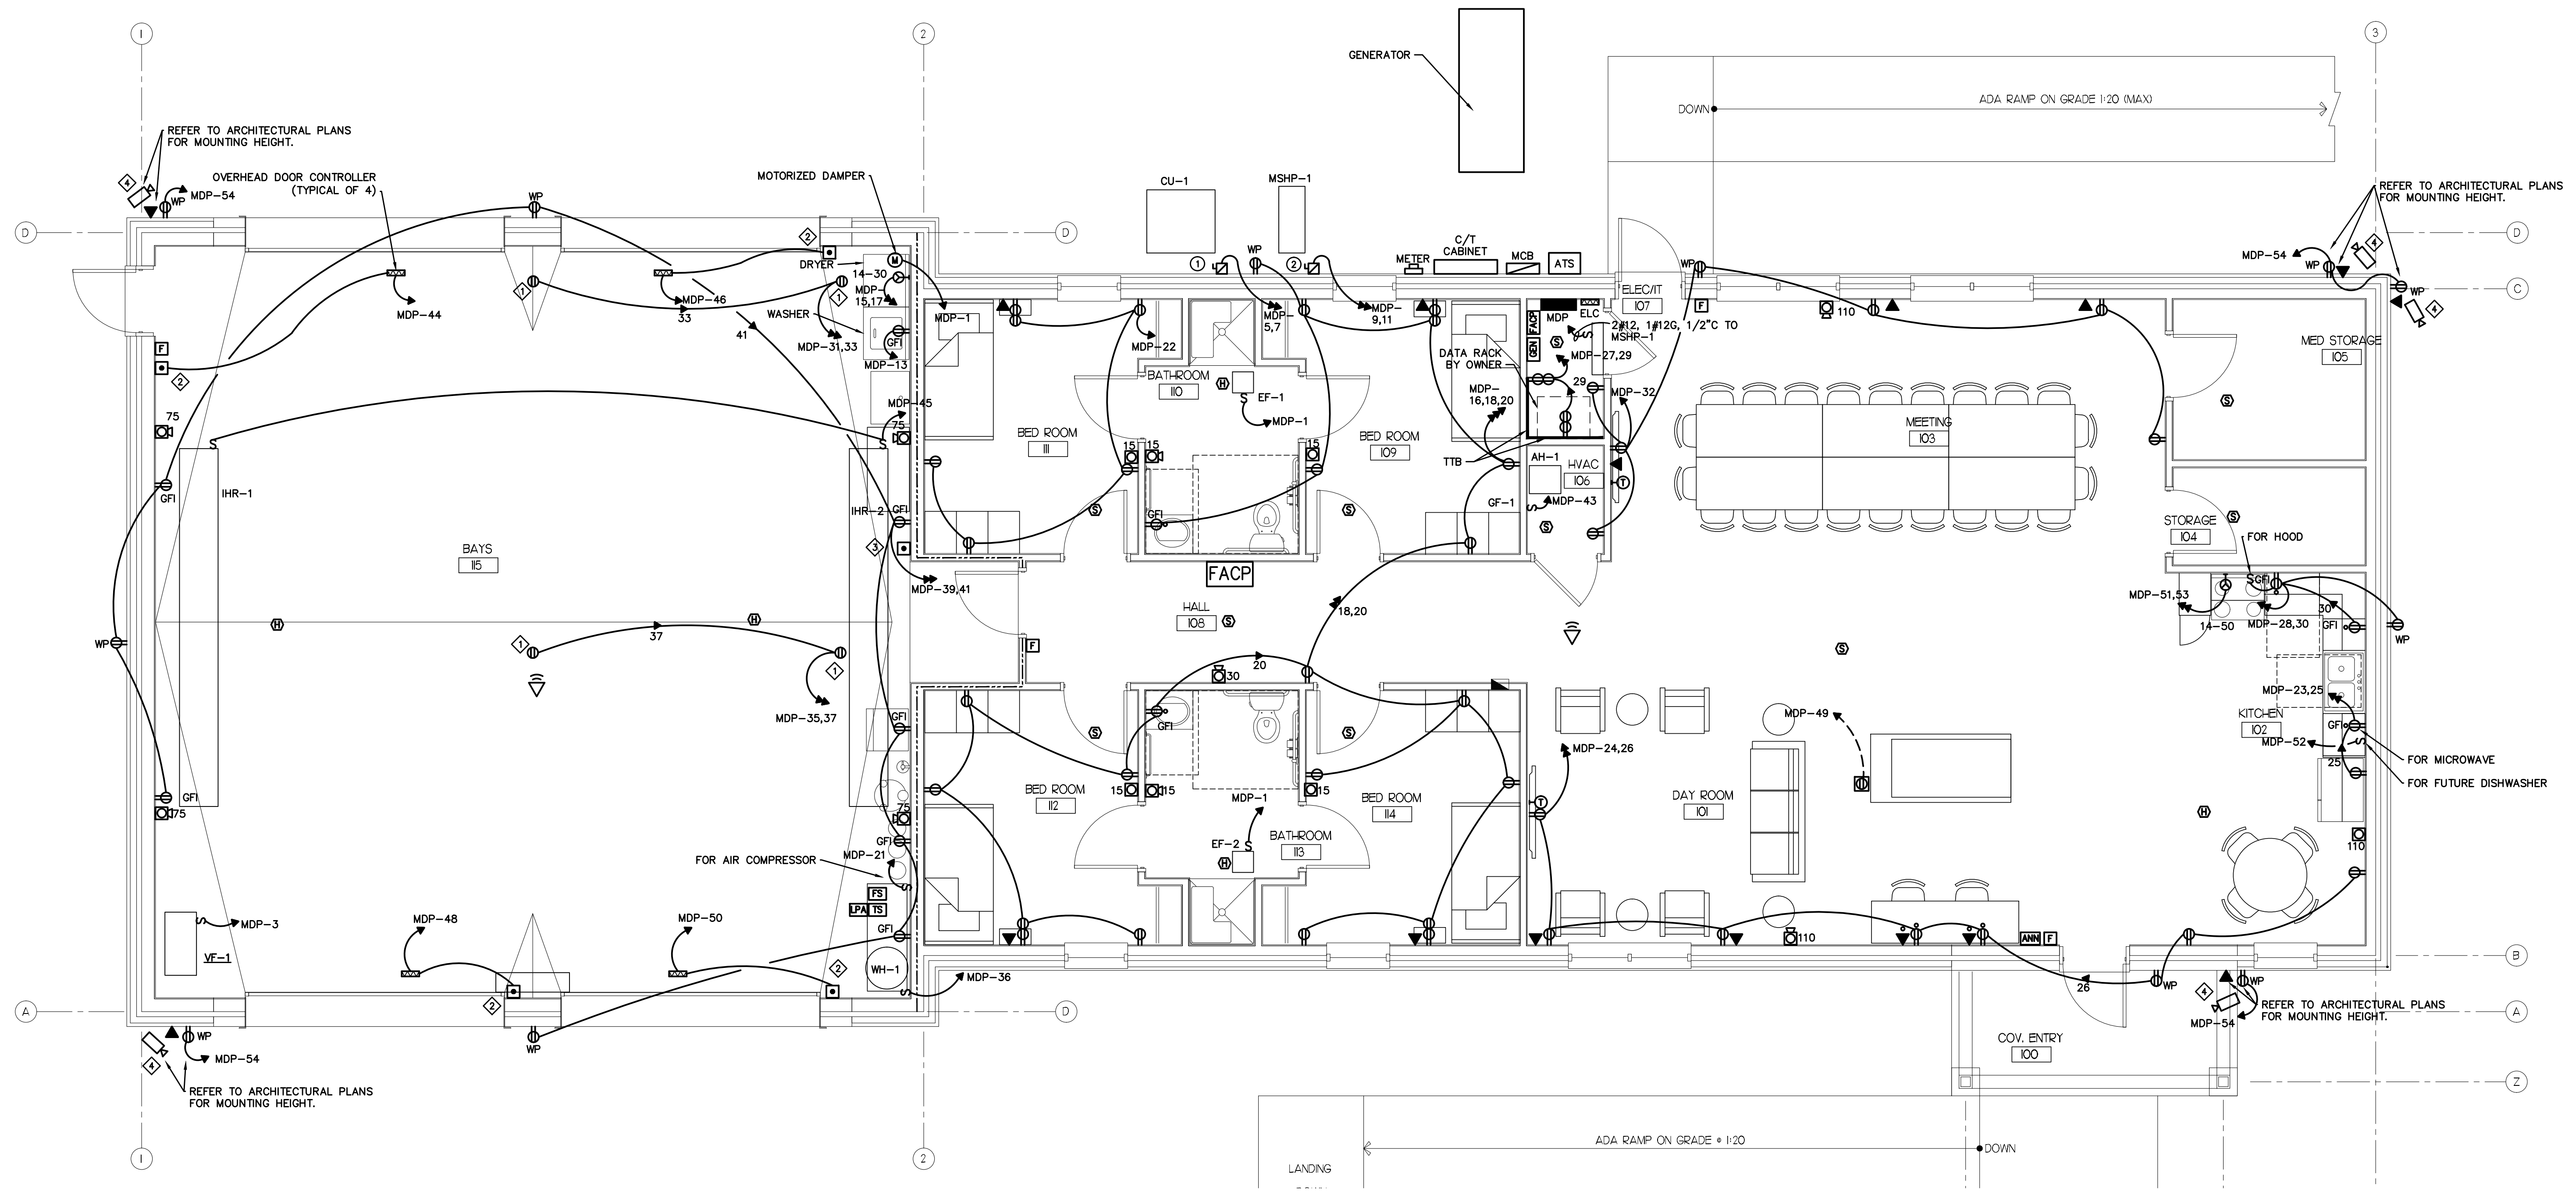

1 FLOOR PLAN
E-3.1 SCALE: 1/4" = 1'-0"

- NOTES:
- ◇ PROVIDE CEILING RECEPTACLE AND CORD REEL REFER TO DETAIL FOR MORE INFORMATION.
 - ◇ PROVIDE 1" FROM OVERHEAD DOOR CONTROLLER (ABOVE) TO CONTROL STATION ON WALL. DOOR CONTROLLER AND CONTROL STATION PROVIDED WITH DOOR.
 - ◇ PROVIDE 1" TO EACH OVERHEAD CONTROLLER (4 TOTAL) TO MASTER CONTROL STATION ON WALL. DOOR CONTROLLER AND CONTROL STATION PROVIDED WITH DOOR.
 - ◇ VERIFY LOCATION OF ALL SECURITY EQUIPMENT PRIOR TO INSTALLATION OF CONDUIT OR OUTLETS.