


3 GAS PIPING SCHEMATIC
M-1.1 NTS

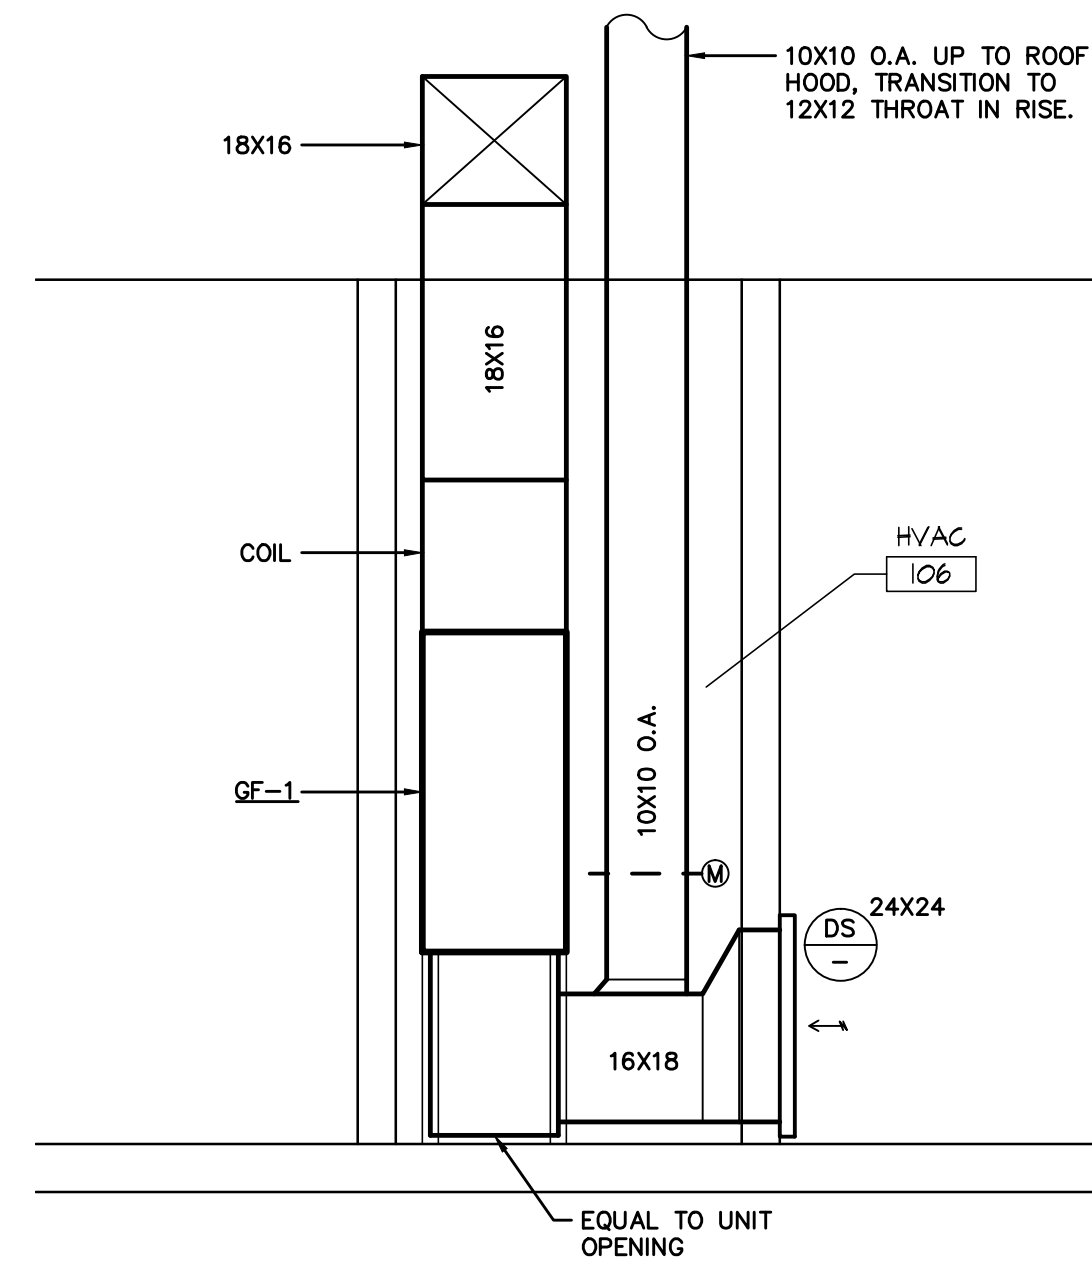

2 SECTION AT GAS FURNACE
M-1.1 SCALE: 1/2" = 1'-0"


NOTES:

- ROUTE 1-1/4" C.D. TO FLOOR DRAIN.
- CONCENTRIC VENT THRU ROOF. SIZE PER MFG. RECOMMENDATIONS. SEE DETAIL 12/M3-3.1.
- 8" Ø UP TO ROOF CAP. SEE 9/M-3.1.

SIZE ALL REFRIGERANT PIPING PER MFG. RECOMMENDATIONS.

SEE ARCHITECTURAL ELEVATIONS FOR EXACT LOUVER LOCATIONS.

DUCT RUNOUTS EQUAL TO GRILLE AND DIFFUSER NECK SIZES UNLESS NOTED OTHERWISE.

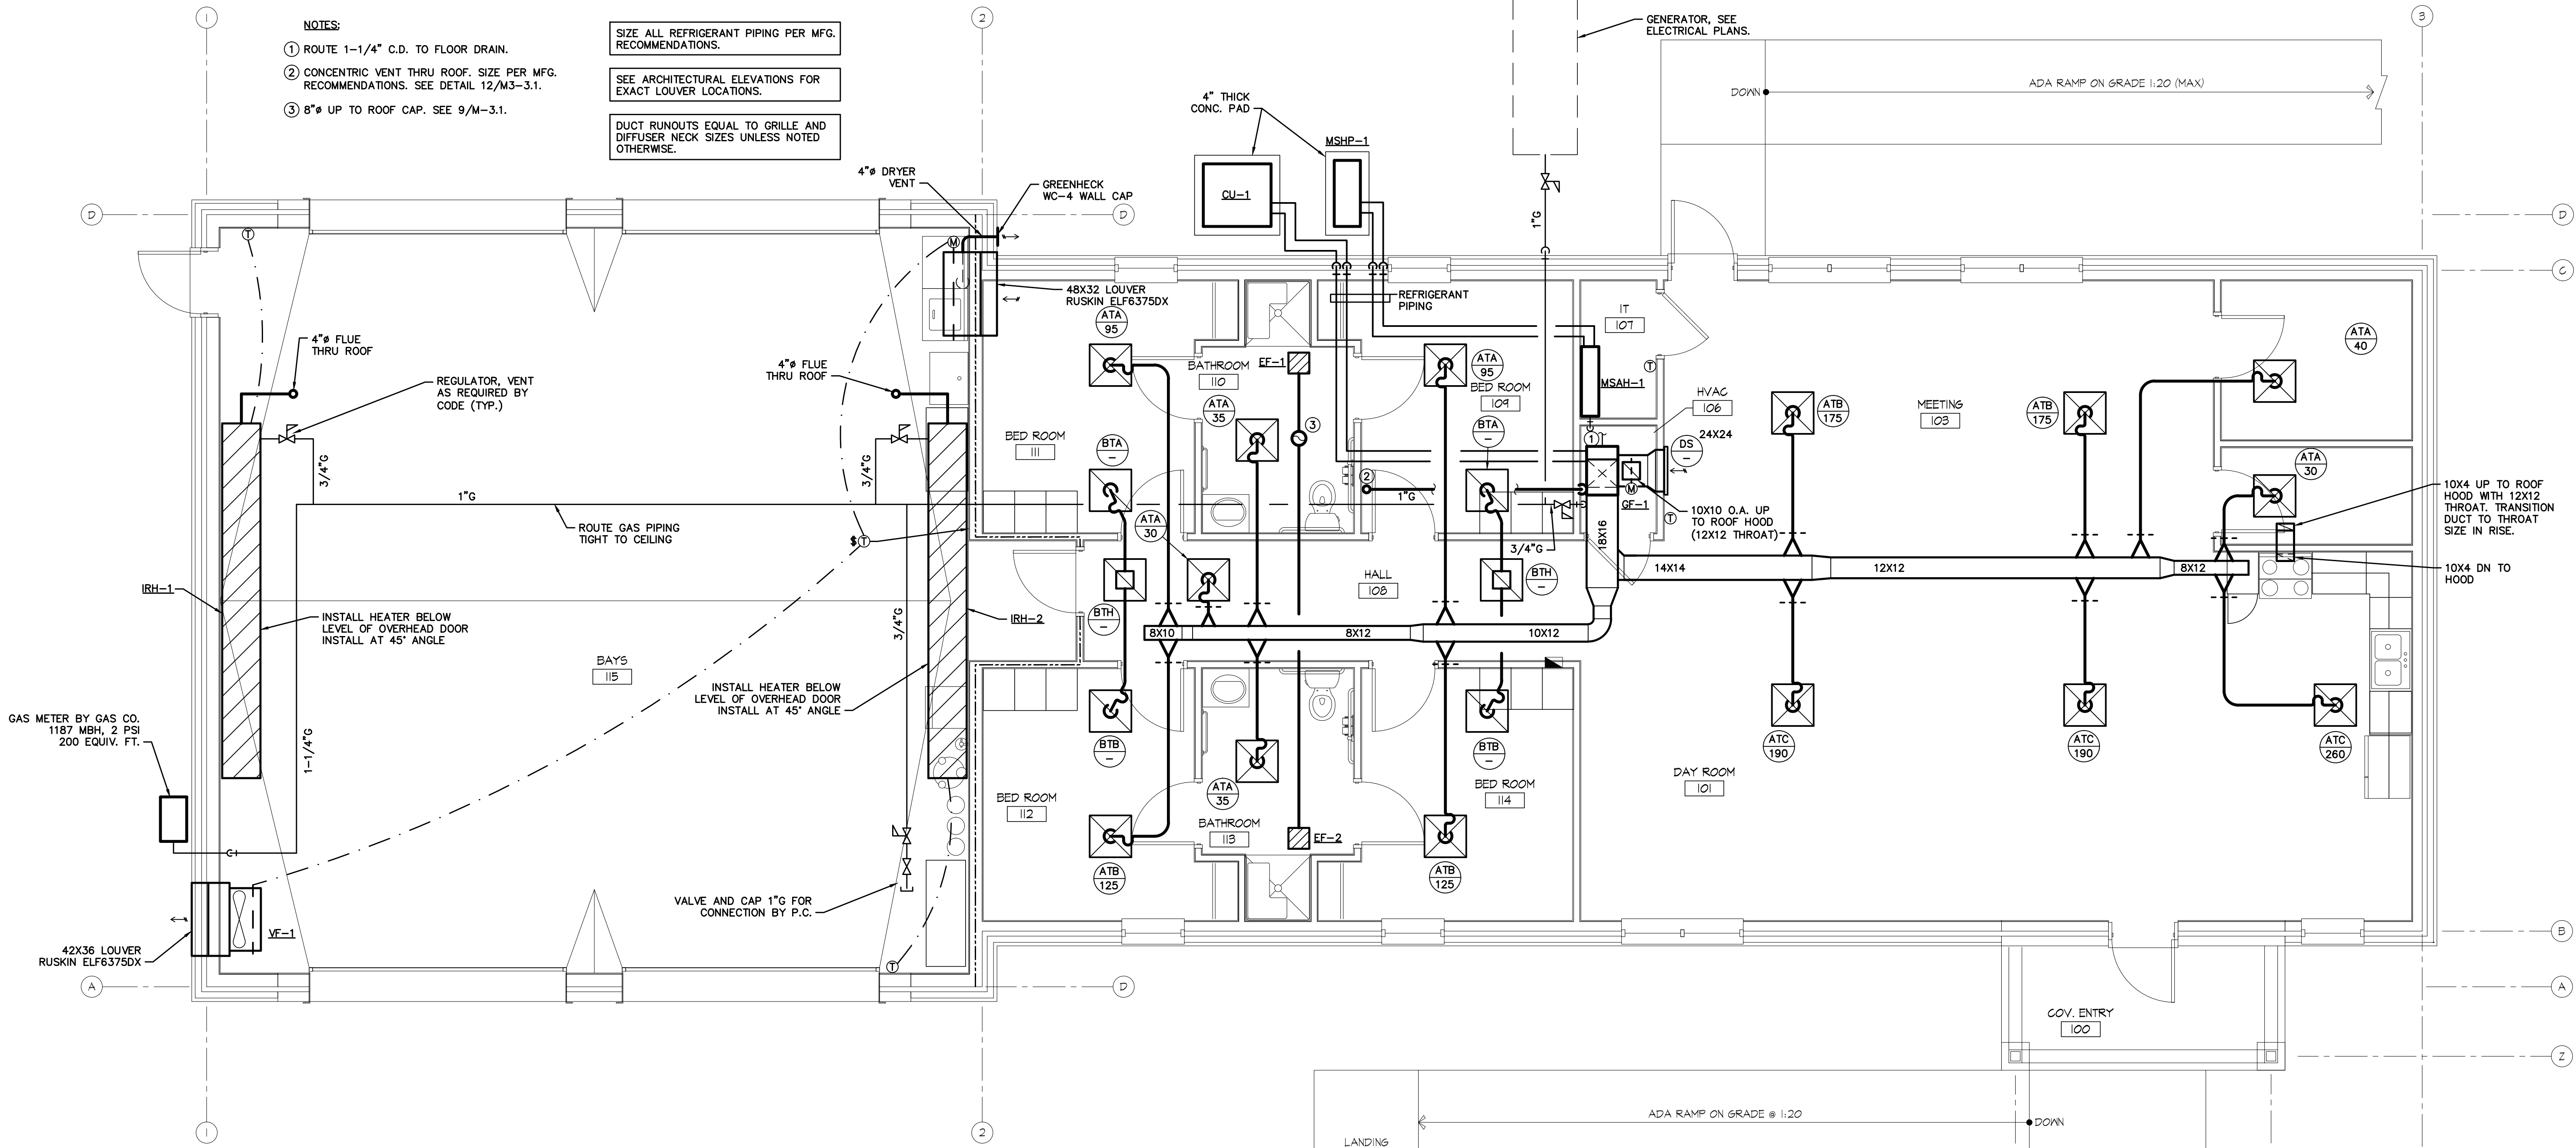

1 FLOOR PLAN
M-1.1 SCALE: 1/4" = 1'-0"

**McKNIGHT SMITH
WARD GRIFFIN**
ENGINEERS, INCORPORATED
Charlotte, NC
704/757-2112



1300 South Mint Street, Suite 300, Charlotte, NC 28203
Email: esd@esdarch.com • Phone: 704-373-0902 • Fax: 704-373-1900



**SOUTHEASTERN EMS
NEW SOUTHEASTERN EMS
FOR
RUTHERFORD COUNTY**

ISSUE DATE: 10-7-14
REVISION 1: _____
REVISION 2: _____
REVISION 3: _____
REVISION 4: _____
PROJECT #: 14-190-000
CONTENT: _____
PROJECT ENGINEER: JCC
DRAWN BY: MSB
CADD FILE NAME: _____

THIS DRAWING AND THE DESIGN SHOWN ARE THE PROPERTY OF ESD. THE REPRODUCTION, OR USE OF THIS DRAWING WITHOUT THE WRITTEN CONSENT IS PROHIBITED. ANY INFRINGEMENT IS SUBJECT TO LEGAL ACTION.

Sheet
M-1.1