

SOUTHEASTERN EMS  
NEW SOUTHEASTERN EMS  
FOR  
RUTHERFORD COUNTY

ISSUE DATE: 10-7-14

REVISION 1: \_\_\_\_\_  
REVISION 2: \_\_\_\_\_  
REVISION 3: \_\_\_\_\_  
REVISION 4: \_\_\_\_\_


PROJECT #: 14-190-000  
CONTENT: \_\_\_\_\_

PROJECT ENGINEER: JCC  
DRAWN BY: AE  
CADD FILE NAME: \_\_\_\_\_


THIS DRAWING AND THE DESIGN SHOWN ARE THE PROPERTY OF ESD. THE REPRODUCTION, OR USE OF THIS DRAWING WITHOUT THE WRITTEN CONSENT IS PROHIBITED. ANY INFRINGEMENT IS SUBJECT TO LEGAL ACTION.

Sheet


P-1.1

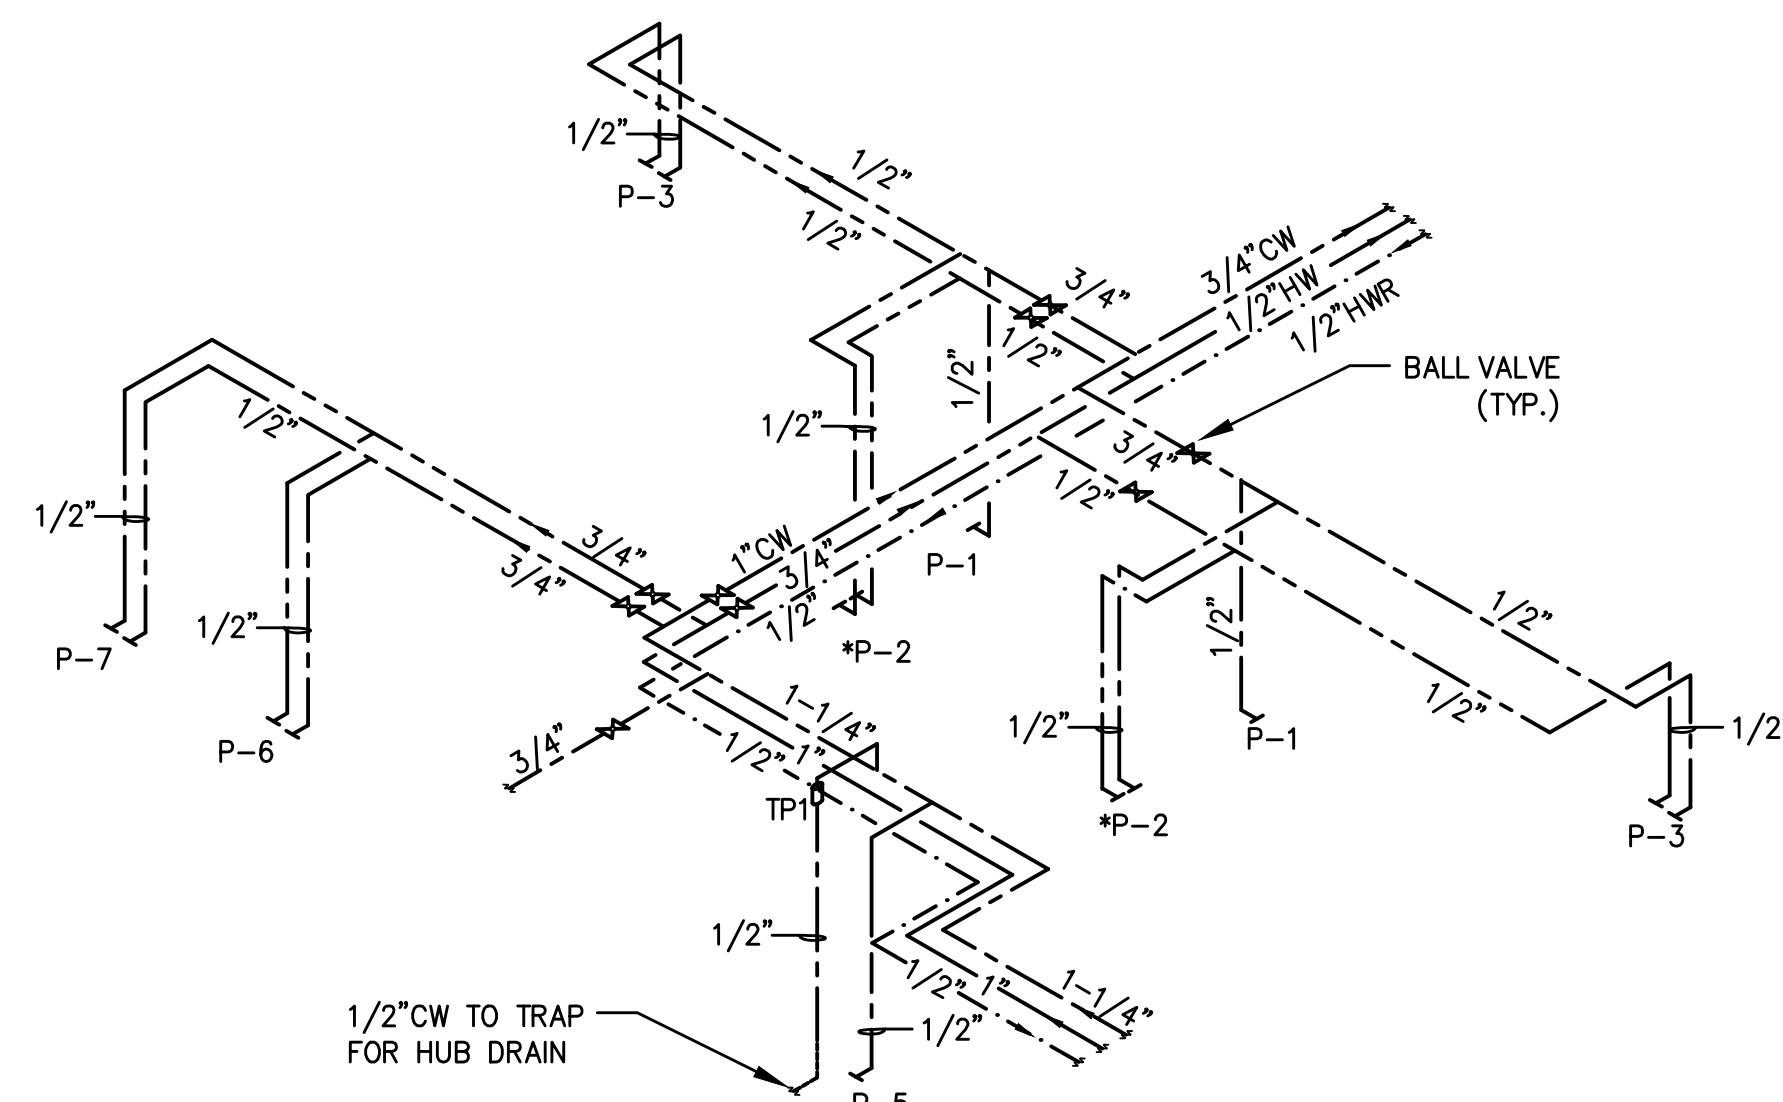

3 WATER PIPING SCHEMATIC  
P-1.1 NTS

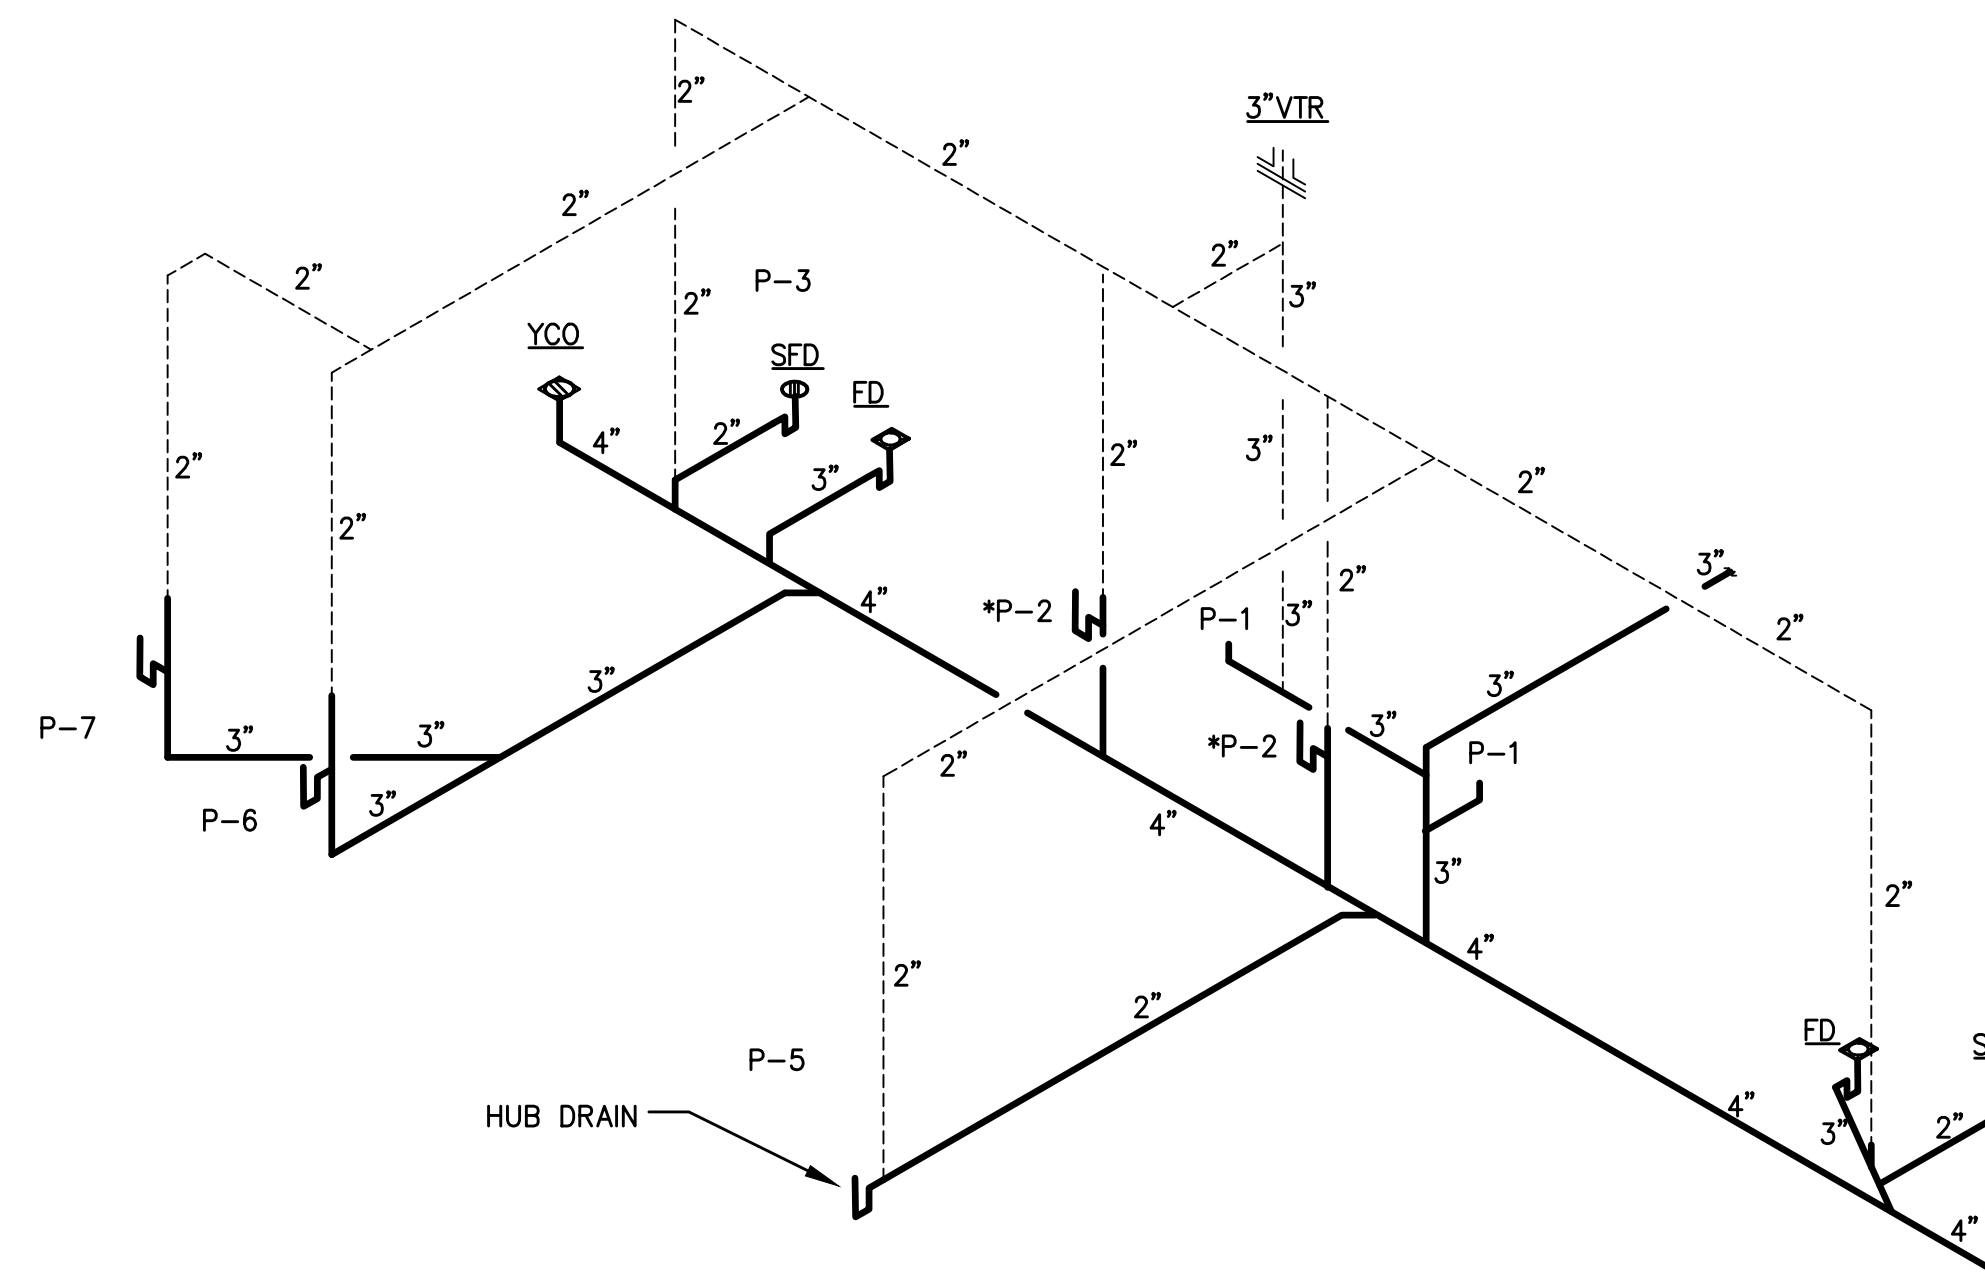

2 WASTE PIPING SCHEMATIC  
P-1.1 NTS

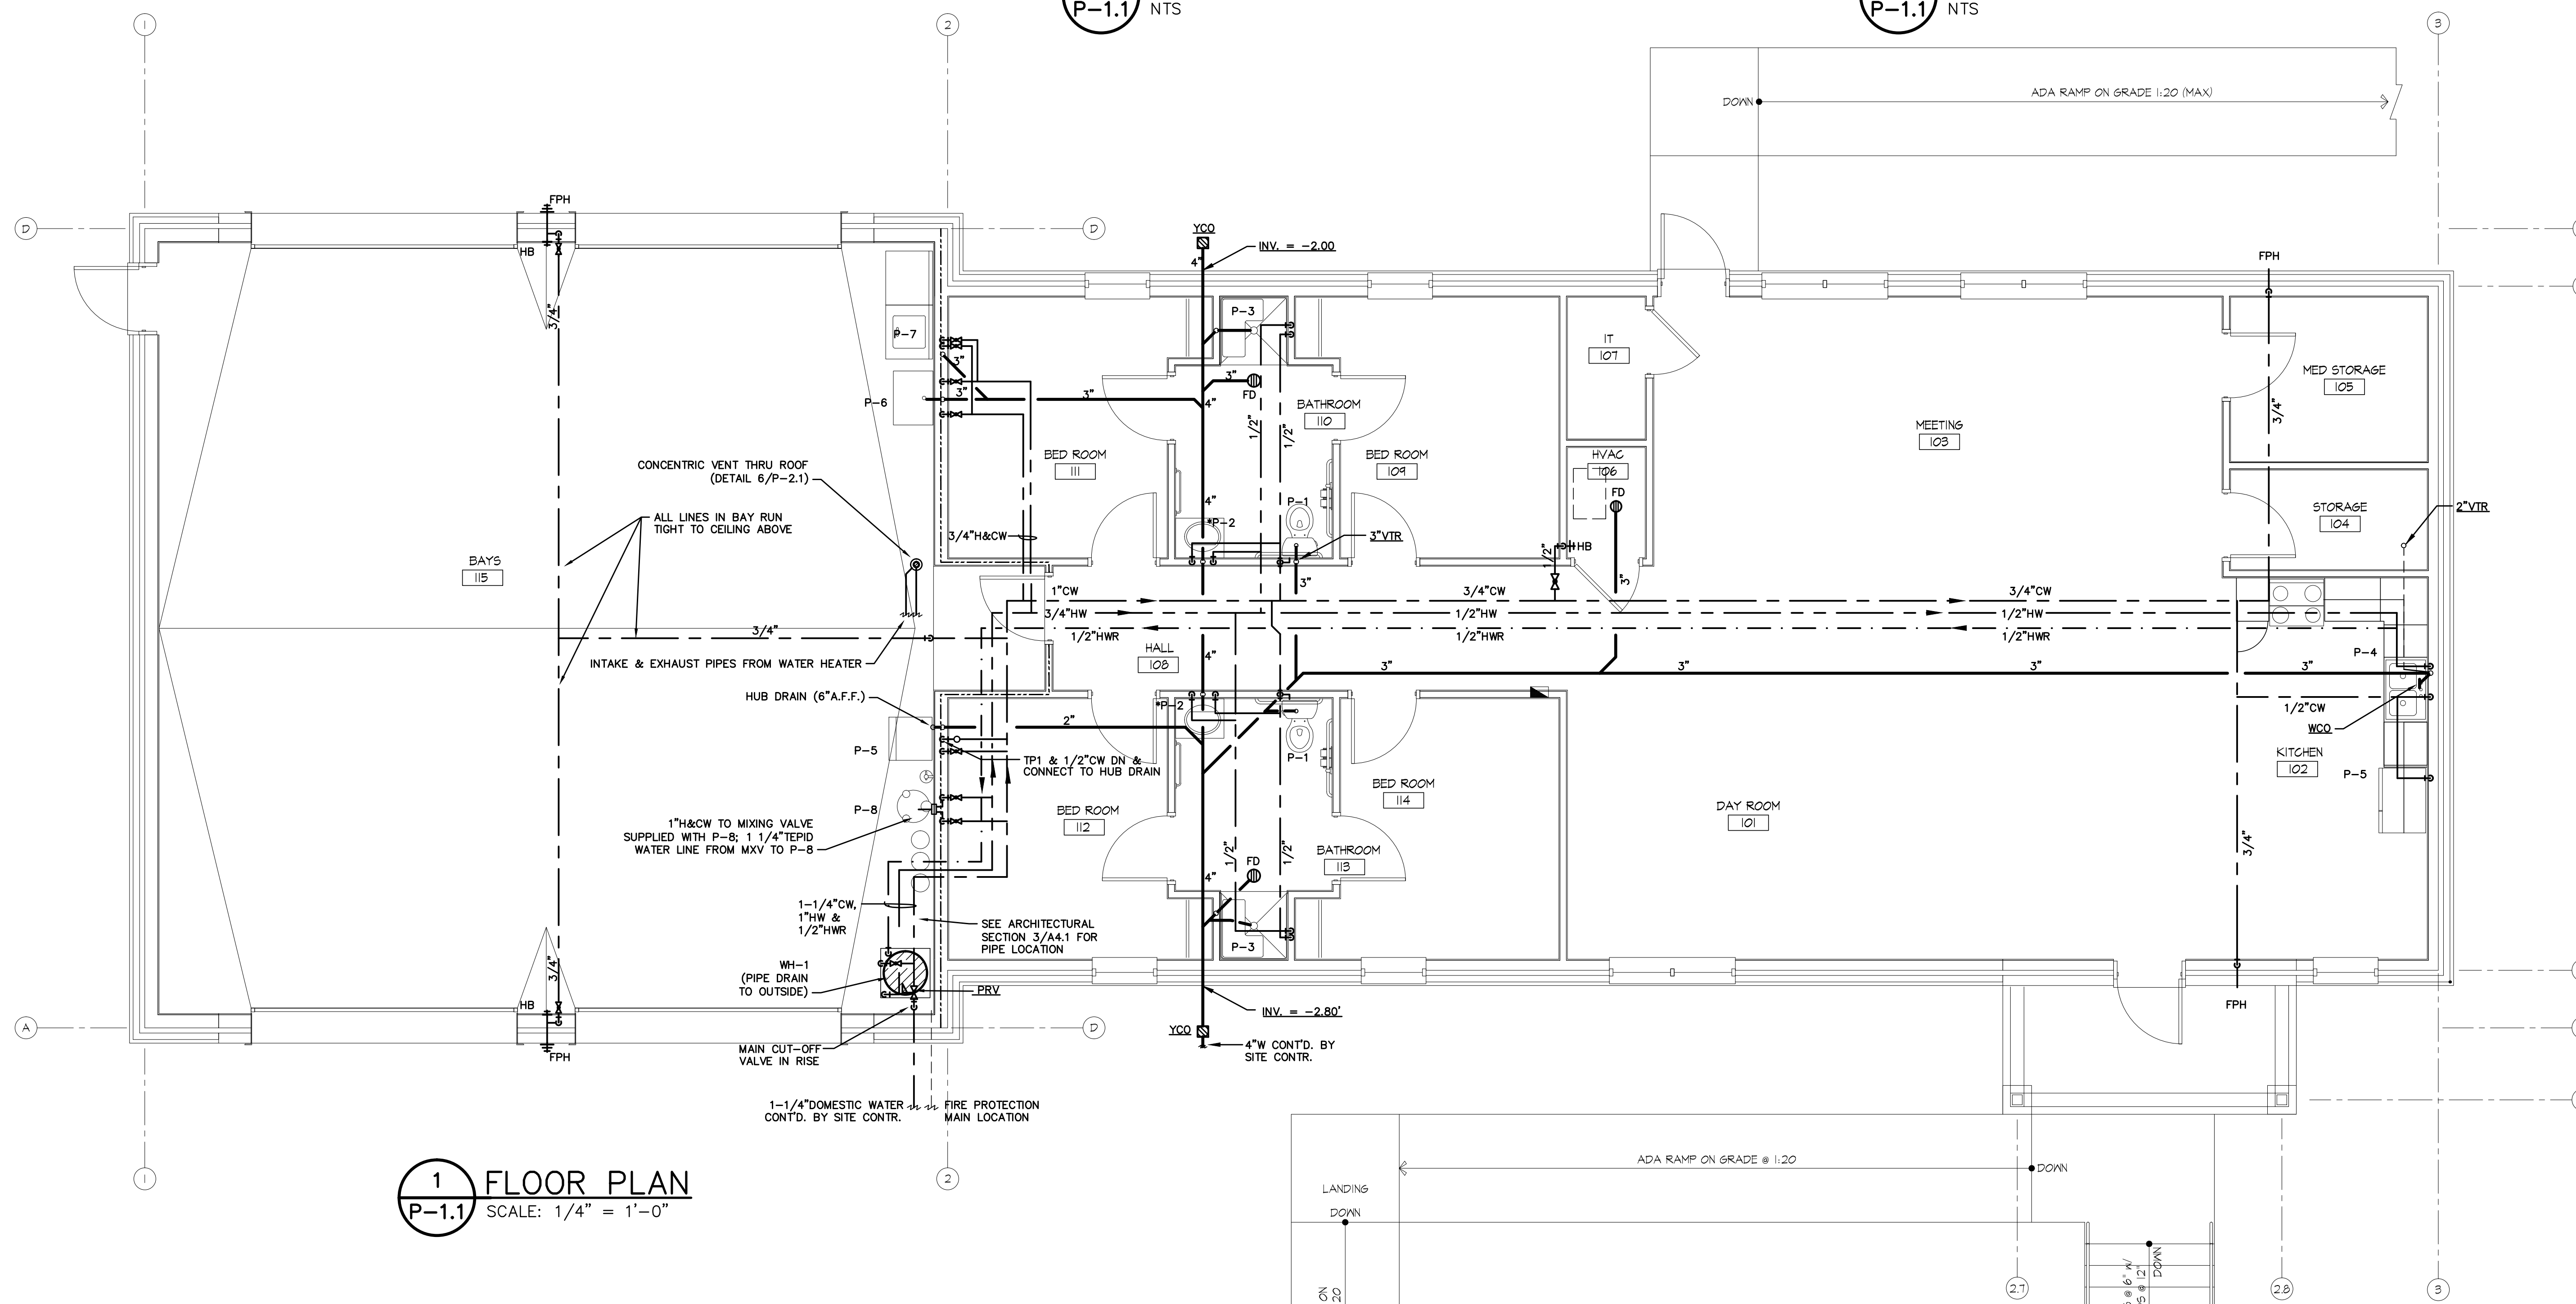

1 FLOOR PLAN  
P-1.1 SCALE: 1/4" = 1'-0"